

Legend:

LIGHTING



- OVERDOOR IP65 LED LUMINAIRE C/W AMBER OPTIC TO BE MOUNTED OVER CABIN DOORS. PIR OPERATED.
- POST TOP IP65 LED LUMINAIRE C/W 2m COLUMN & AMBER OPTIC. EX2 DENOTES GUN HEAD
- LED BOLLARD



LUMINAIRE SCHEDULE - LDL LIGHTING - design@dl.lighting


SYMBOL	QUANTITY	DESCRIPTION
	17	5M COLUMN C/W LDL LIGHTING STREET S L4 AMBER OPTIC16W 1600LM
	5	5M COLUMN C/W BACK TO BACK (500MM OUTREACH) LDL LIGHTING STREET S L4 AMBER OPTIC 16W 1600LM
	119	LDL LIGHTING LEAH DIRECT 7W 800LM AMBER - ABOVE EACH CABIN DOOR. C/W AMBER OPTICS
	1	LDL LIGHTING HAMPSHIRE 1m 10W AMBER BOLLARD

ALL DOORWAY LIGHTING TO BE INDIVIDUALLY PIR CONTROLLED

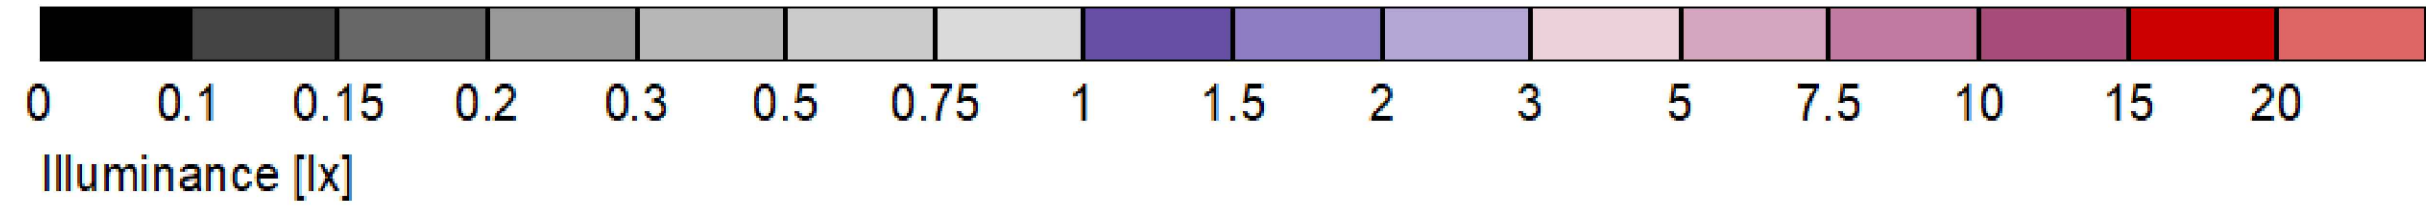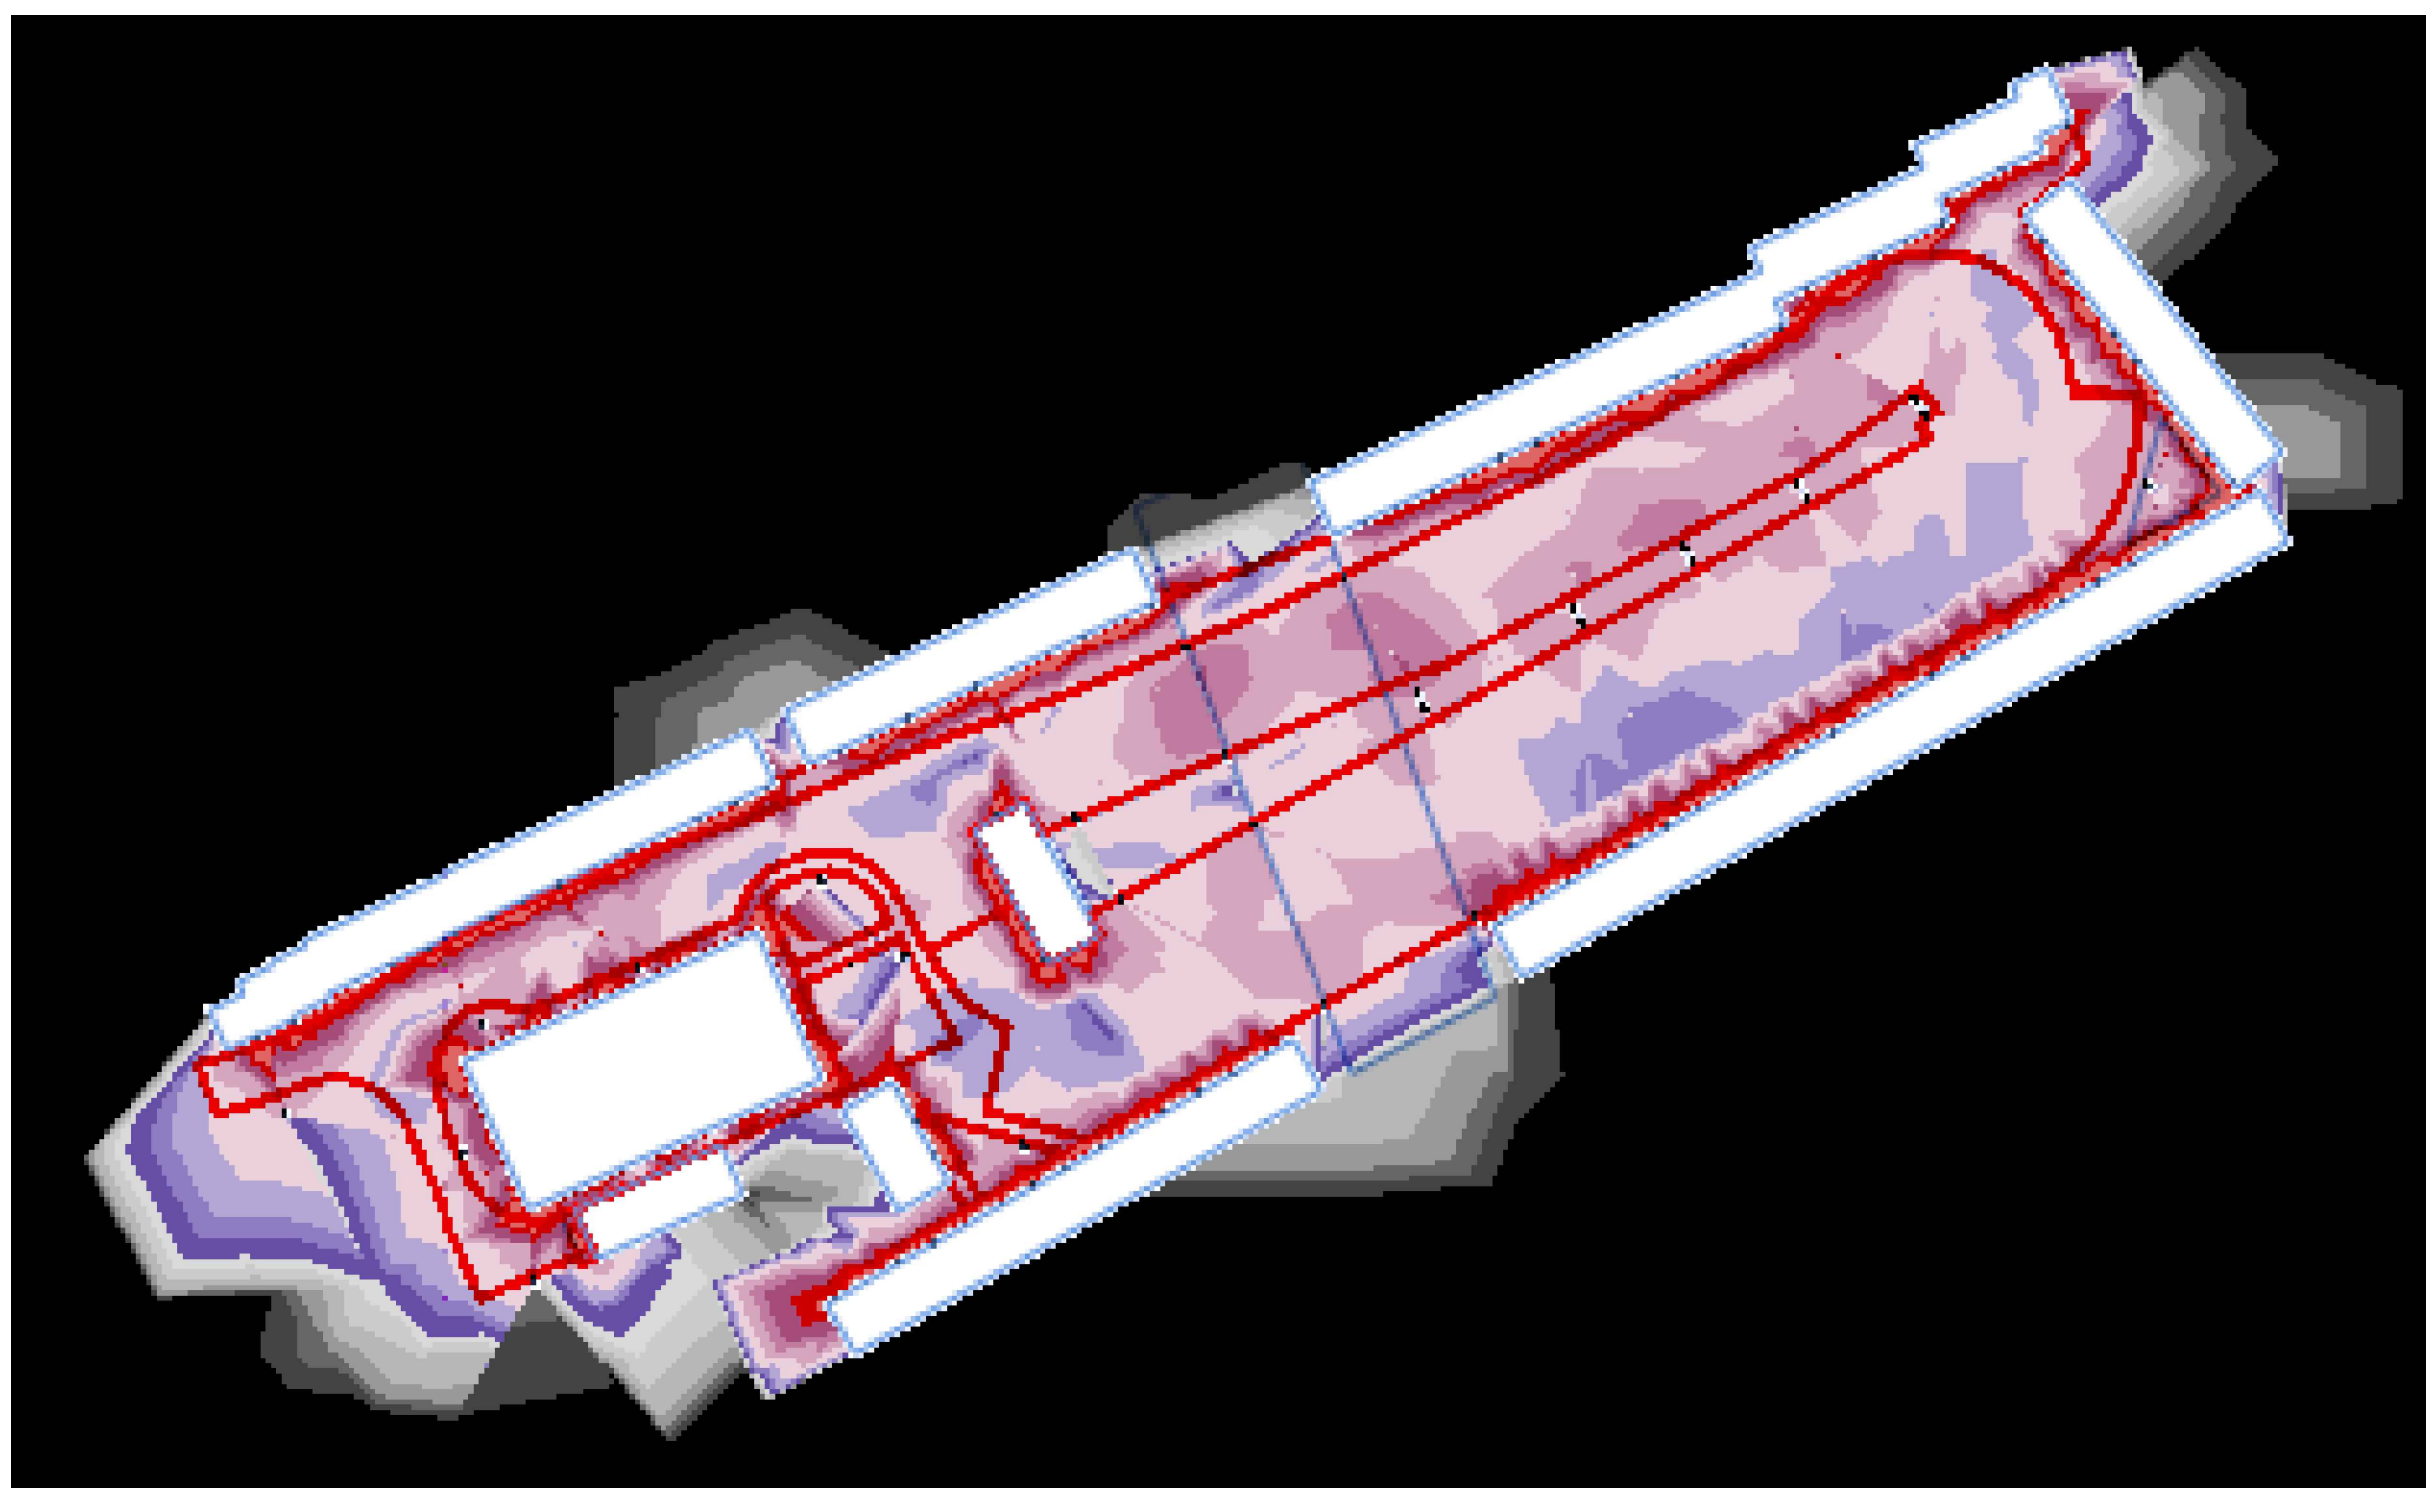

FALSE COLOUR RENDER.
NOT TO SCALE

CALCULATION SUMMARY						
AREA	UNITS	Em	Emin	Emax	Uo	ULR
CAR PARK	LUX	5	1	27	0.27	0.00

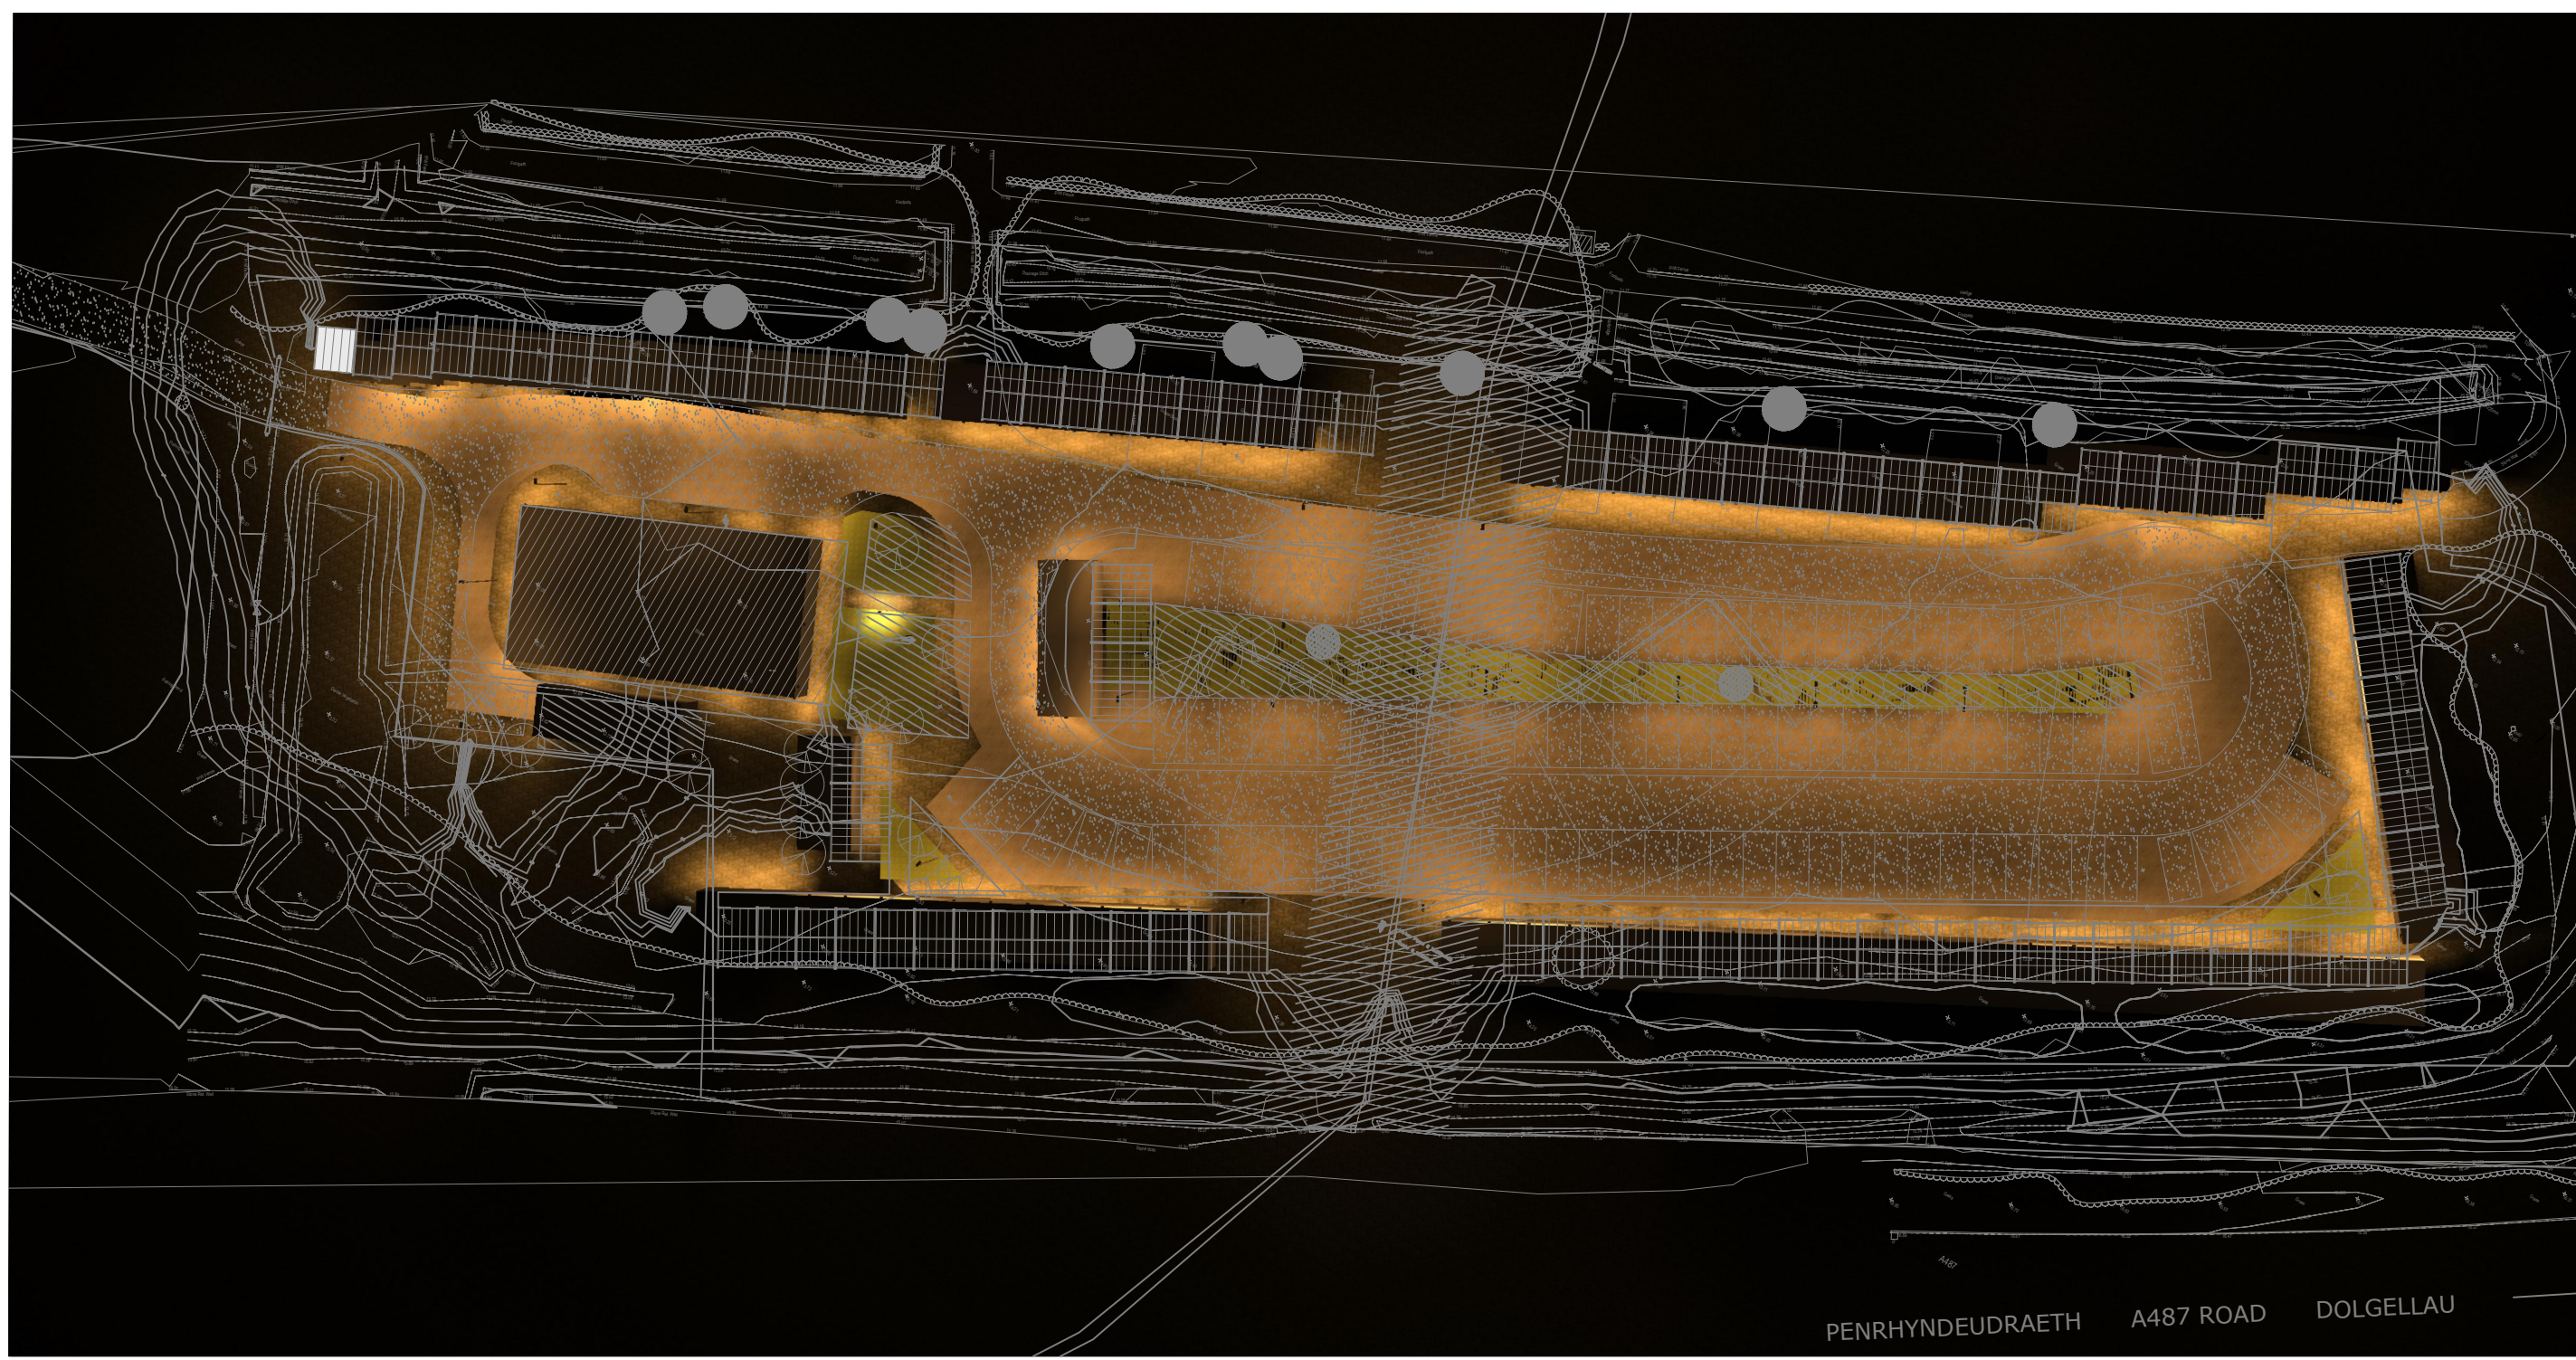

3D ILLUMINANCE OVERLAID WITHIN 2D PLAN
FOR INDICATIVE DISTRIBUTION.
NOT TO SCALE.

ALL OF THESE RED ZEROS
DENOTE ZERO LUX SPILL
CALCULATED AROUND THE
PERIMETER OF THE SITE.

CONTOUR LINE	LUX LEVEL
	0.08
	0.10
	0.15
	0.20
	0.25



PROPOSED 3D LUMINANCE VIEWS

NOTES:

- ALL DIMENSIONS IN METRES UNLESS SHOWN OTHERWISE
- DO NOT SCALE FROM DRAWINGS
- THIS DRAWING SHALL BE READ IN CONJUNCTION WITH THE SPECIFICATIONS AND ALL RELEVANT
- ALL WORKMANSHIP AND MATERIALS SHALL BE IN ACCORDANCE WITH THE RELEVANT SPECIFICATIONS

Rev	By	Chk'd	Auth'd	Date	Description
C03	TC	JH	PH	10/23	Construction issue
C02	TC	JH	PH	10/23	Construction issue
C01	TC	JH	PH	08/23	Construction issue

Client :

nationalgrid

Subcontractor / Designer:



Contractor:



Head Office:
Whitehill House
Windmill Hill Business Park
Whitehill Way
Swindon
SN6 6PE
Tel: 01793 755555
Email:
CADservices@hochtief.co.uk

Project :

SNOWDONIA VIP

Title :
**TEMPORARY ACCOMMODATION
BLAENCEFN
PROPOSED EXTERNAL LIGHTING**

Drawn by : TC	Checked by : JH	Approved by : PH
Date : 30.08.23	Date : 30.08.23	Date : 30.08.23

Drawing Scale & Paper Size : 1:250 Paper Size A0	CAD Filename : Drawing number
---	----------------------------------

Drawing status :
Prelim or Approved for Constr

Drawing No. : C0233-SUP-PTW-CG-DR-X-0001	Revision : C03
--	--------------------------