


©COPYRIGHT CAULMERT LIMITED - NOT TO BE COPIED OR REPRODUCED IN ANY WAY OR FORM WITHOUT PRIOR WRITTEN CONSENT FROM CAULMERT LIMITED

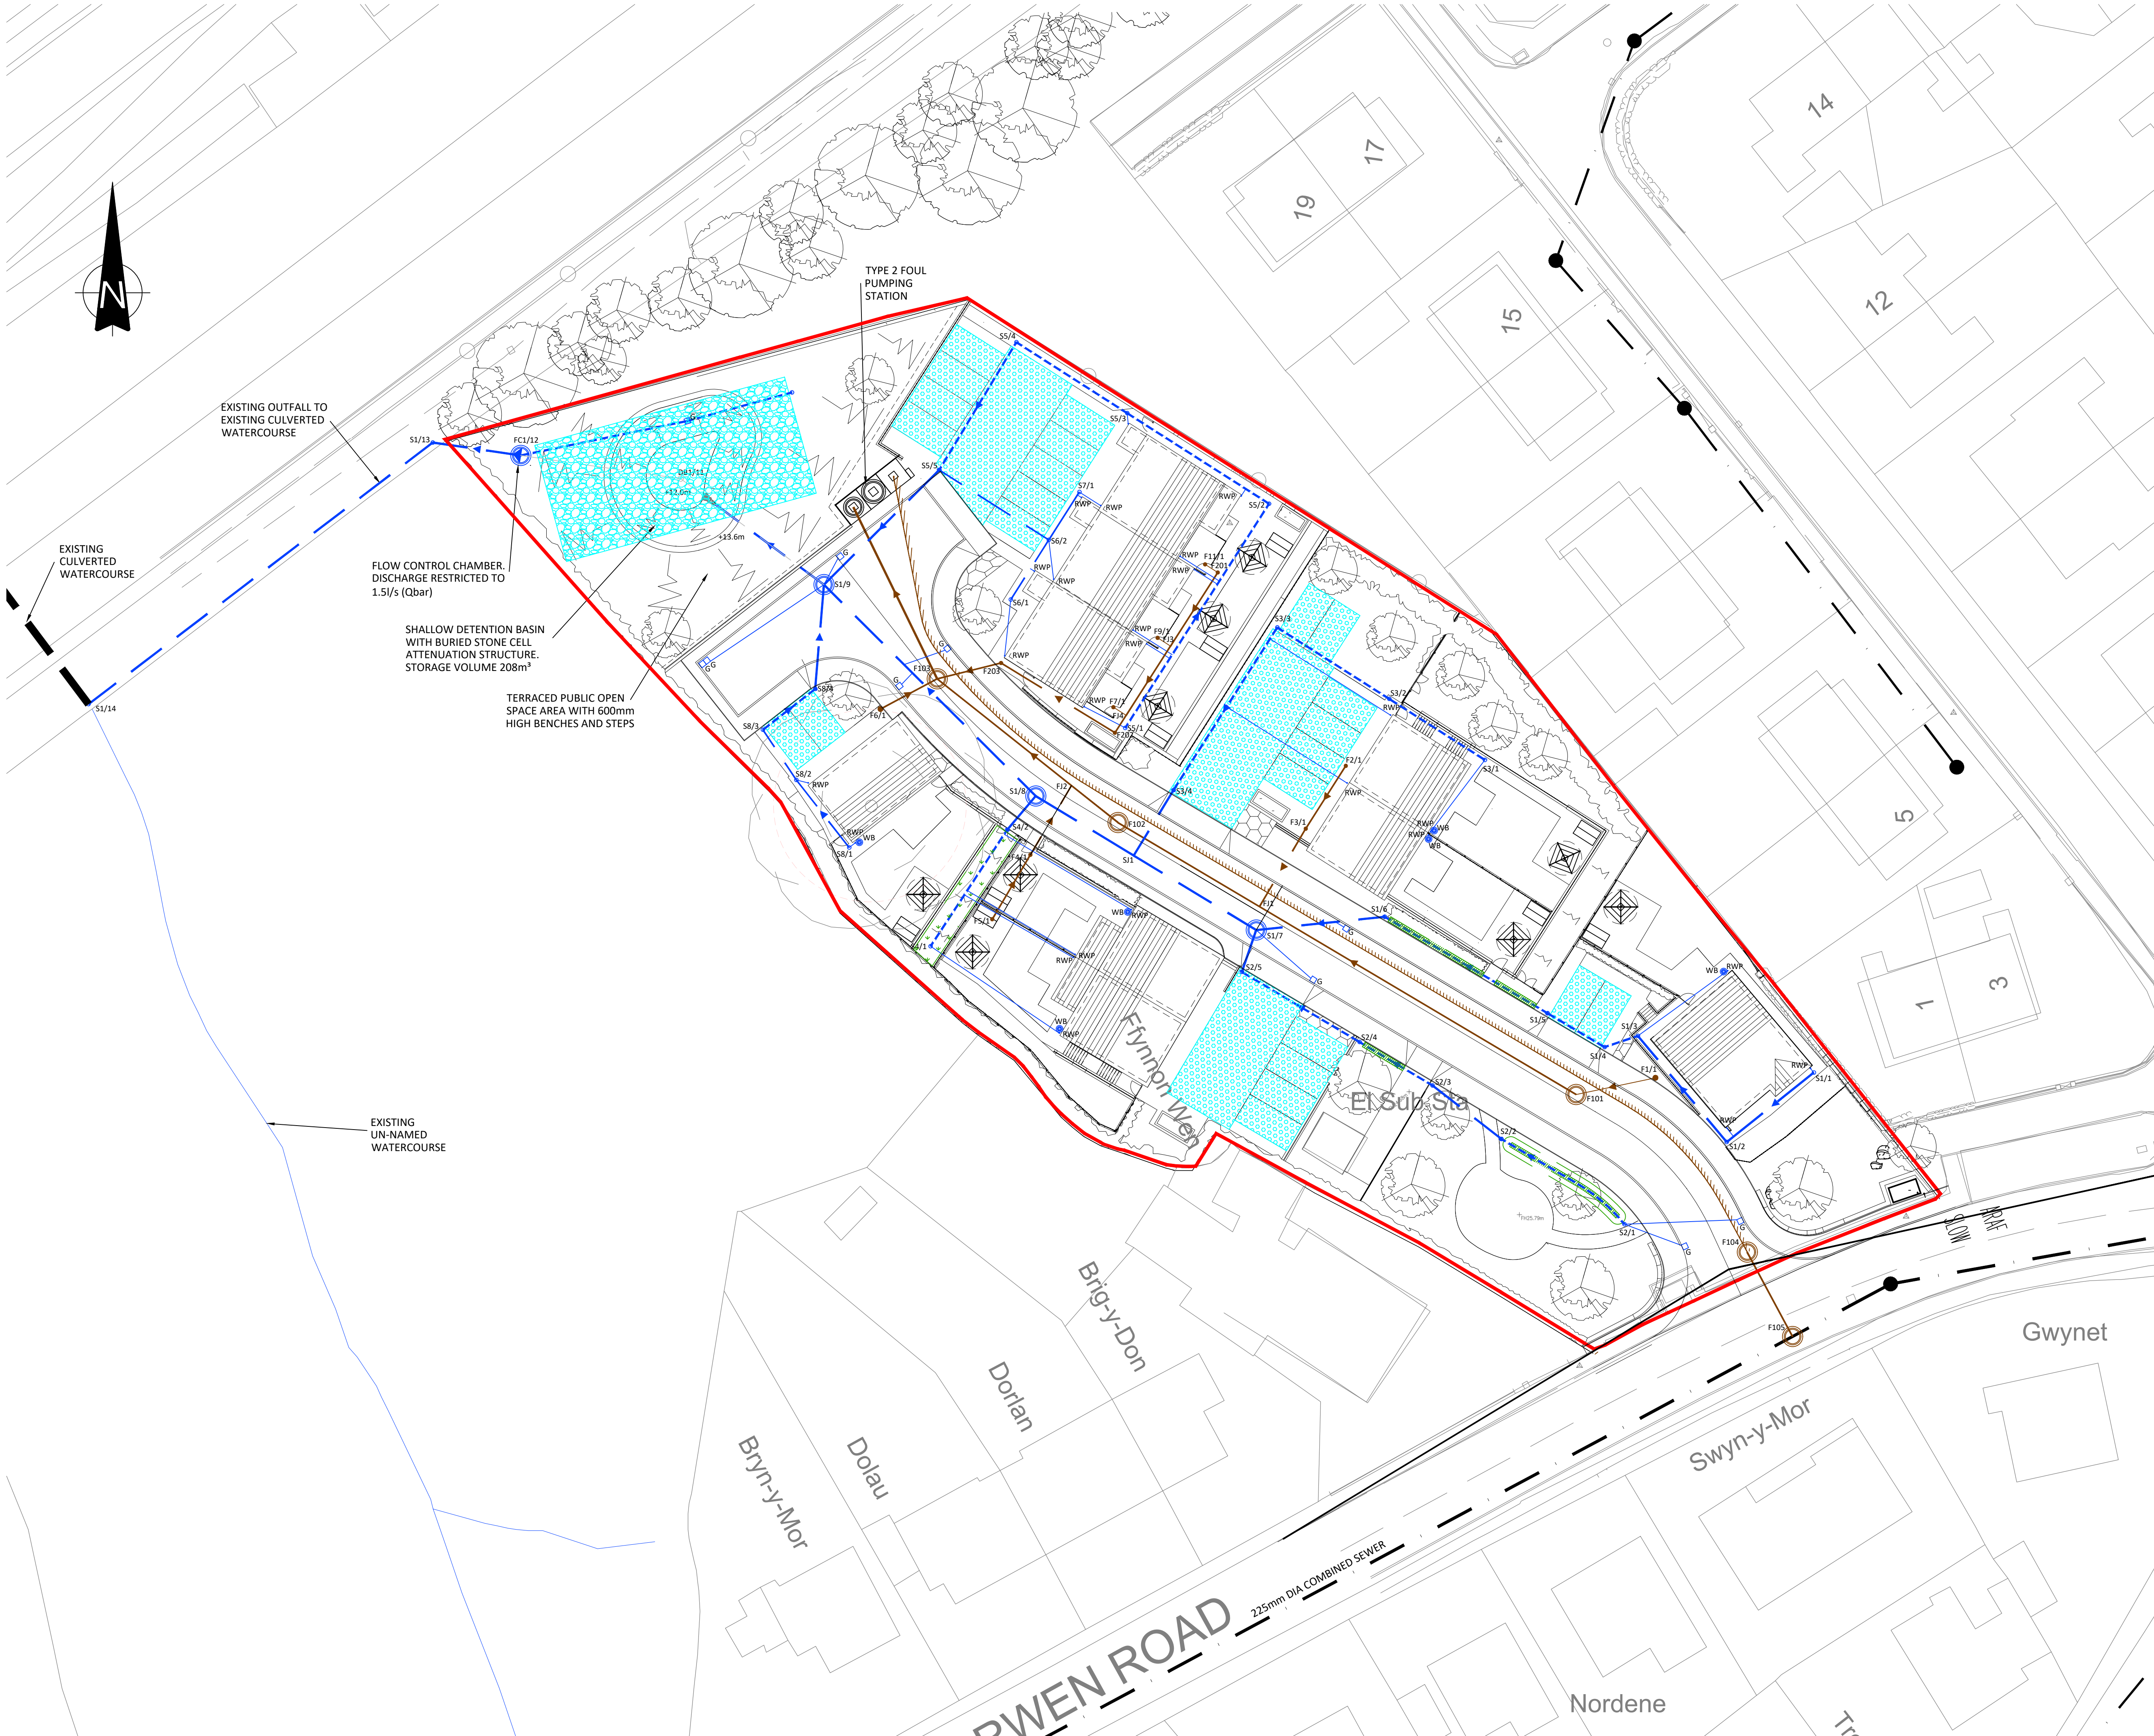

NOTES

- DO NOT SCALE FROM THIS DRAWING. WORK FROM FIGURED DIMENSIONS ONLY. ALL DIMENSIONS ARE IN METRES AND ALL LEVELS ARE IN METRES ABOVE ORDNANCE DATUM UNLESS NOTED OTHERWISE.
- THIS DRAWING IS TO BE READ IN CONJUNCTION WITH ALL RELEVANT ARCHITECTS, ENGINEERS AND SPECIALIST DRAWINGS AND SPECIFICATIONS.

KEY

- SURFACE WATER SOLID CARRIER DRAIN
- SURFACE WATER PERFORATED FILTER DRAIN
- SURFACE WATER INSPECTION CHAMBER
- SURFACE WATER MANHOLE
- SURFACE WATER HYDRO-BRAKE CHAMBER
- SURFACE WATER ORIFICE CONTROL CHAMBER
- FOUL WATER SEWER (ADOPTED)
- FOUL WATER MANHOLE (ADOPTED)
- FOUL WATER INSPECTION CHAMBER M
- FOUL RISING MAIN
- ROAD GULLY
- ACO THRESHOLD CHANNEL OR EQUIVALENT
- POROUS DRIVEWAY ATTENUATION (PRIVATE)
- RAIN GARDEN ATTENUATION (PRIVATE)
- DRY SWALE
- FILTER DRAIN
- 150mm DIAMETER SWALE INLET BY ACO OR EQUIVALENT
- RAINWATER PIPE
- WATER BUTT

PO2	ISSUED FOR PAC CONSULTATION	NWO	NWO	-	27-08-25					
PO1	SAB PRE-APP SUBMISSION	NWO	NWO	-	18-12-24					
REV	MODIFICATIONS	BY	RE	AP	DATE					
PURPOSE OF ISSUE				STATUS						
DRAFT				S0						
CLIENT:										
CARTREFI DEVELOPMENTS LIMITED										
PROJECT:										
DEVELOPMENT SITE OFF YSGUBORWEN ROAD DWYGYFYLCHI										
TITLE:										
FOUL AND SURFACE WATER DRAINAGE LAYOUT										
DESIGNED BY	DRAWN BY	REVIEWED BY	AUTHORISED BY							
NWO	NWO	NWO	-							
DATE	SCALE @ A1	JOB REF:	REVISION							
18-12-24	1:250	6005	PO2							
DRAWING NUMBER										
6005-CAU-XX-XX-DR-C-1600										

Registered Office: Intec, Parc Menai, Bangor, Gwynedd, LL57 4FG Company Registered No: 06716319

WWW.CAULMERT.COM